


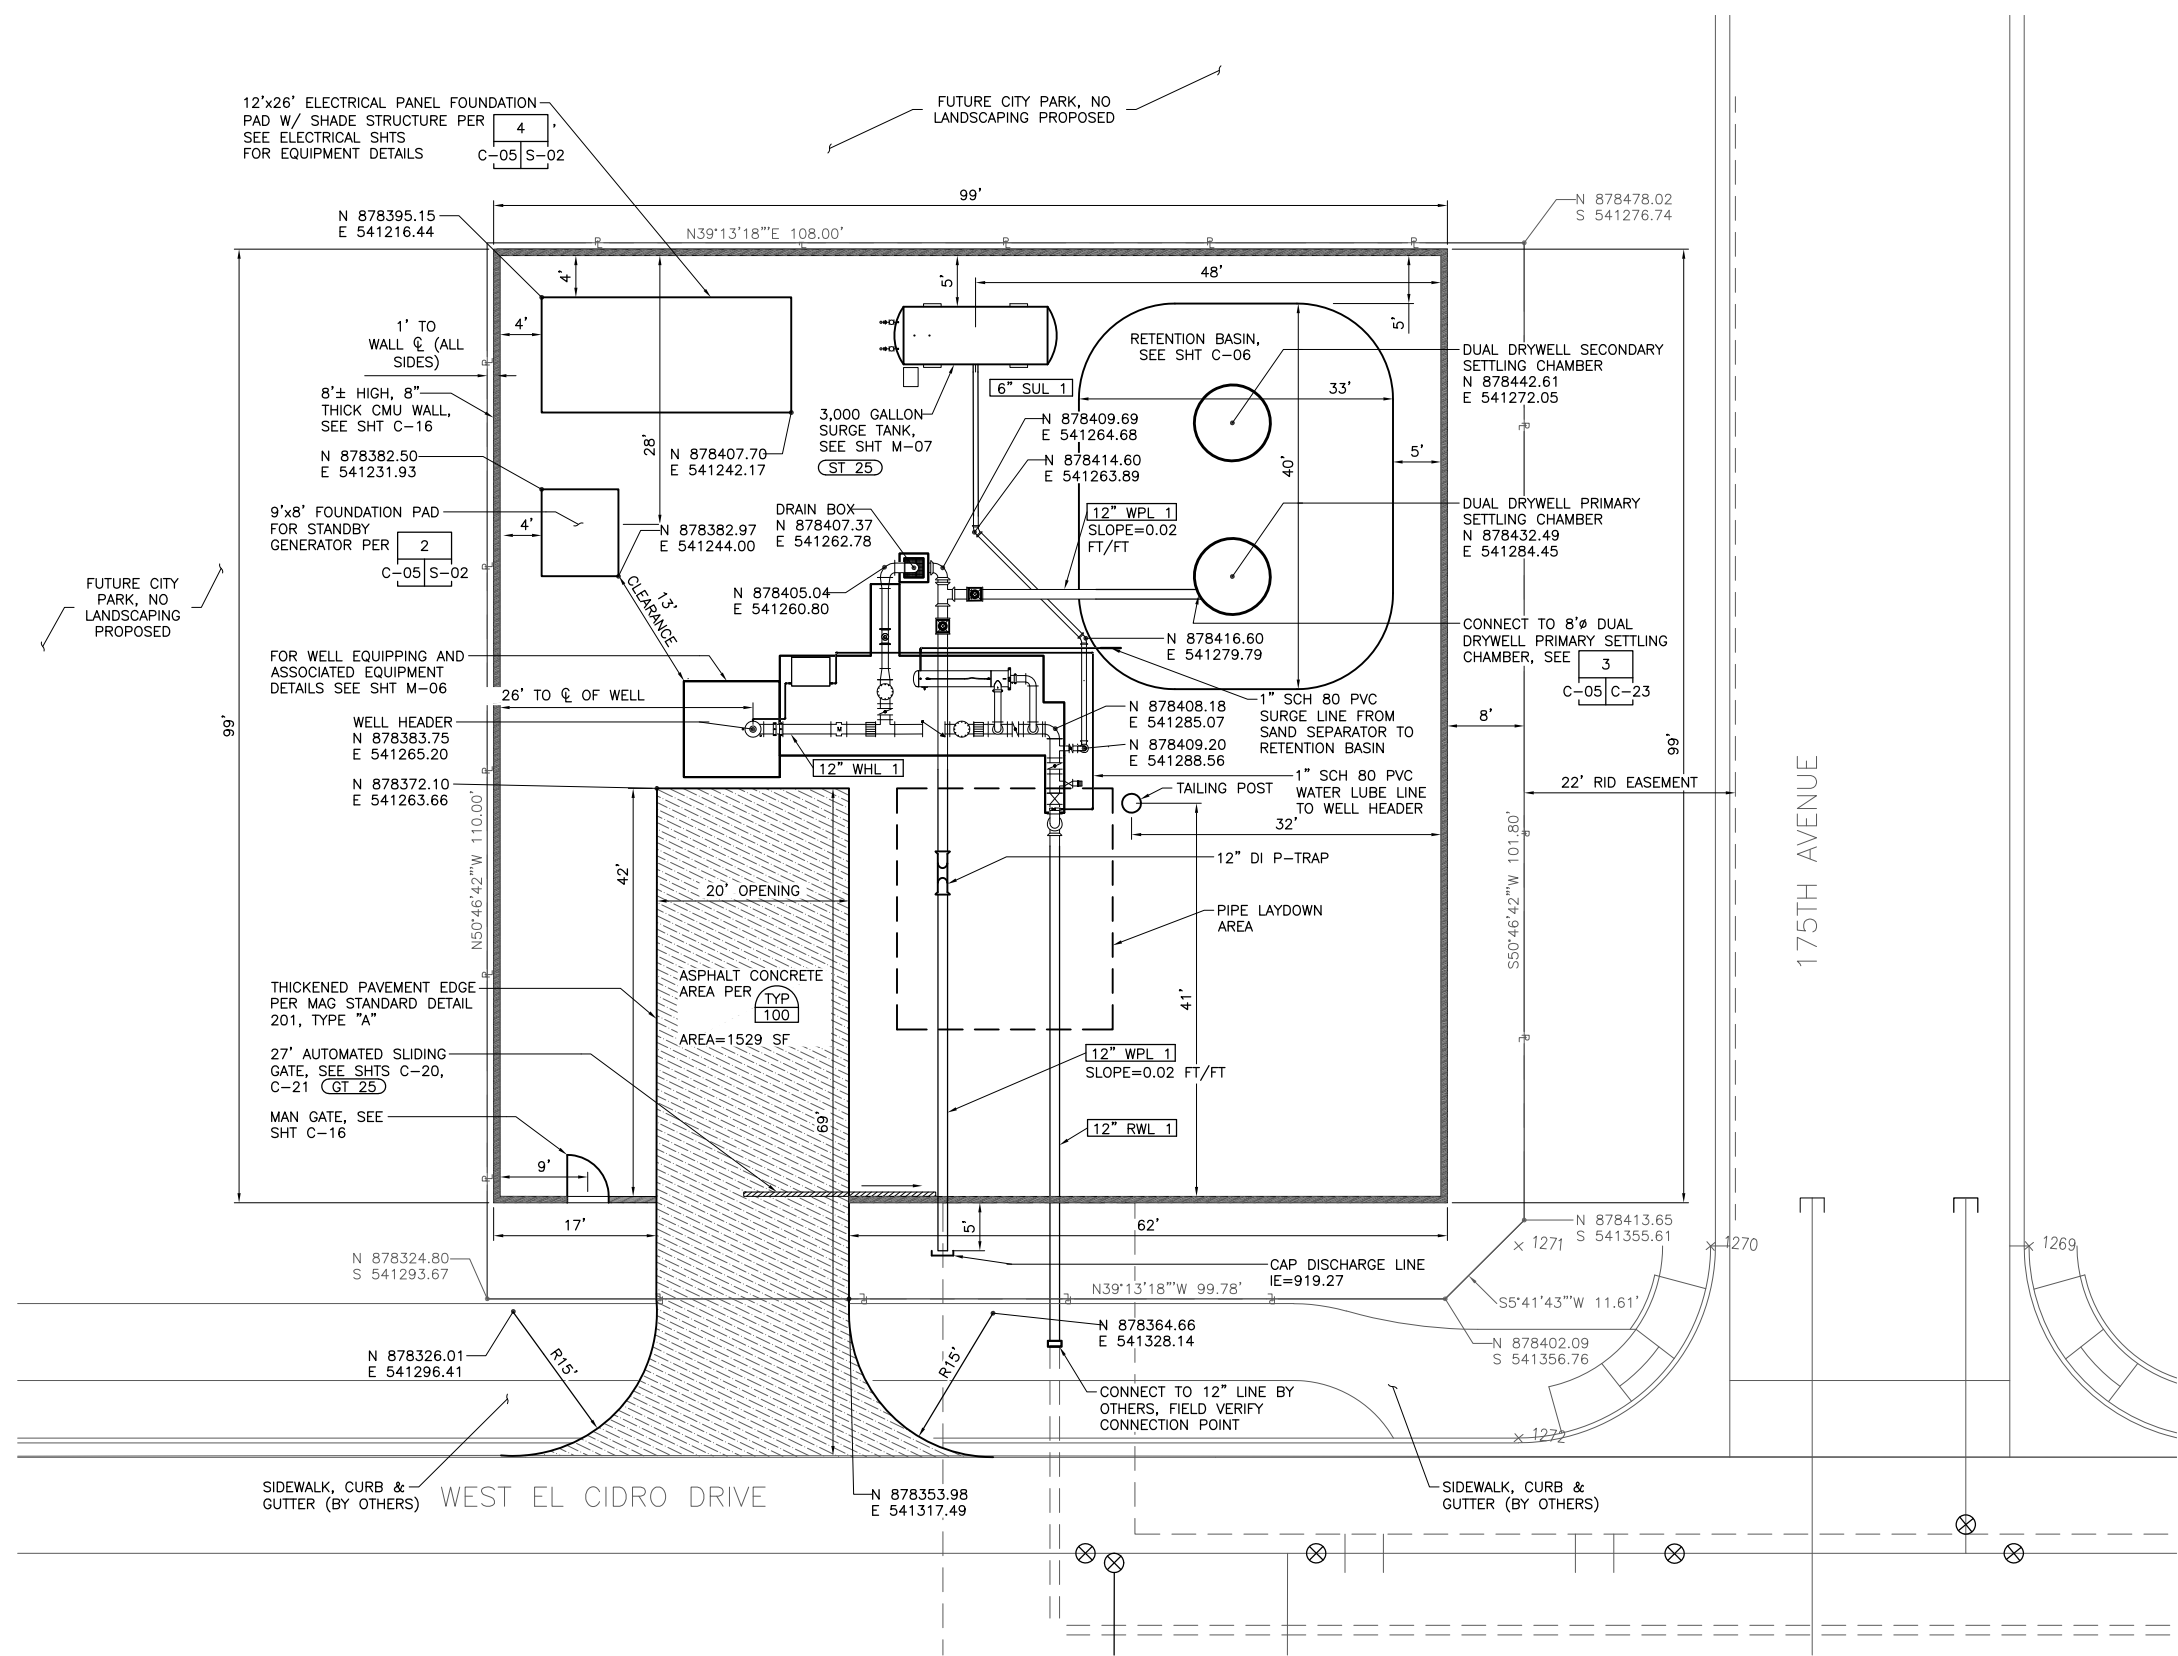

NCS
Engineers
2 E. Earll Drive Suite 110
Phoenix, AZ 85012
Phone (602)629-0206
www.ncseng.com

Sheet Title: WELL 25 CONCEPTUAL SITE PLAN			Drawn By: BSW	Date: 04/09/18
			Design By: SA	Date: 04/09/18
			Approved By: RN	Date: 04/09/18
Project Location: CITY OF GOODYEAR PUBLIC WORKS DEPARTMENT			Project name: SITE 12 TREATMENT EXPANSION – GMP 1 WELLS, TANK AND RO COMPONENTS	
Client Project No.	Project No. 0684	Scale AS NOTED	File Name	Sheet